


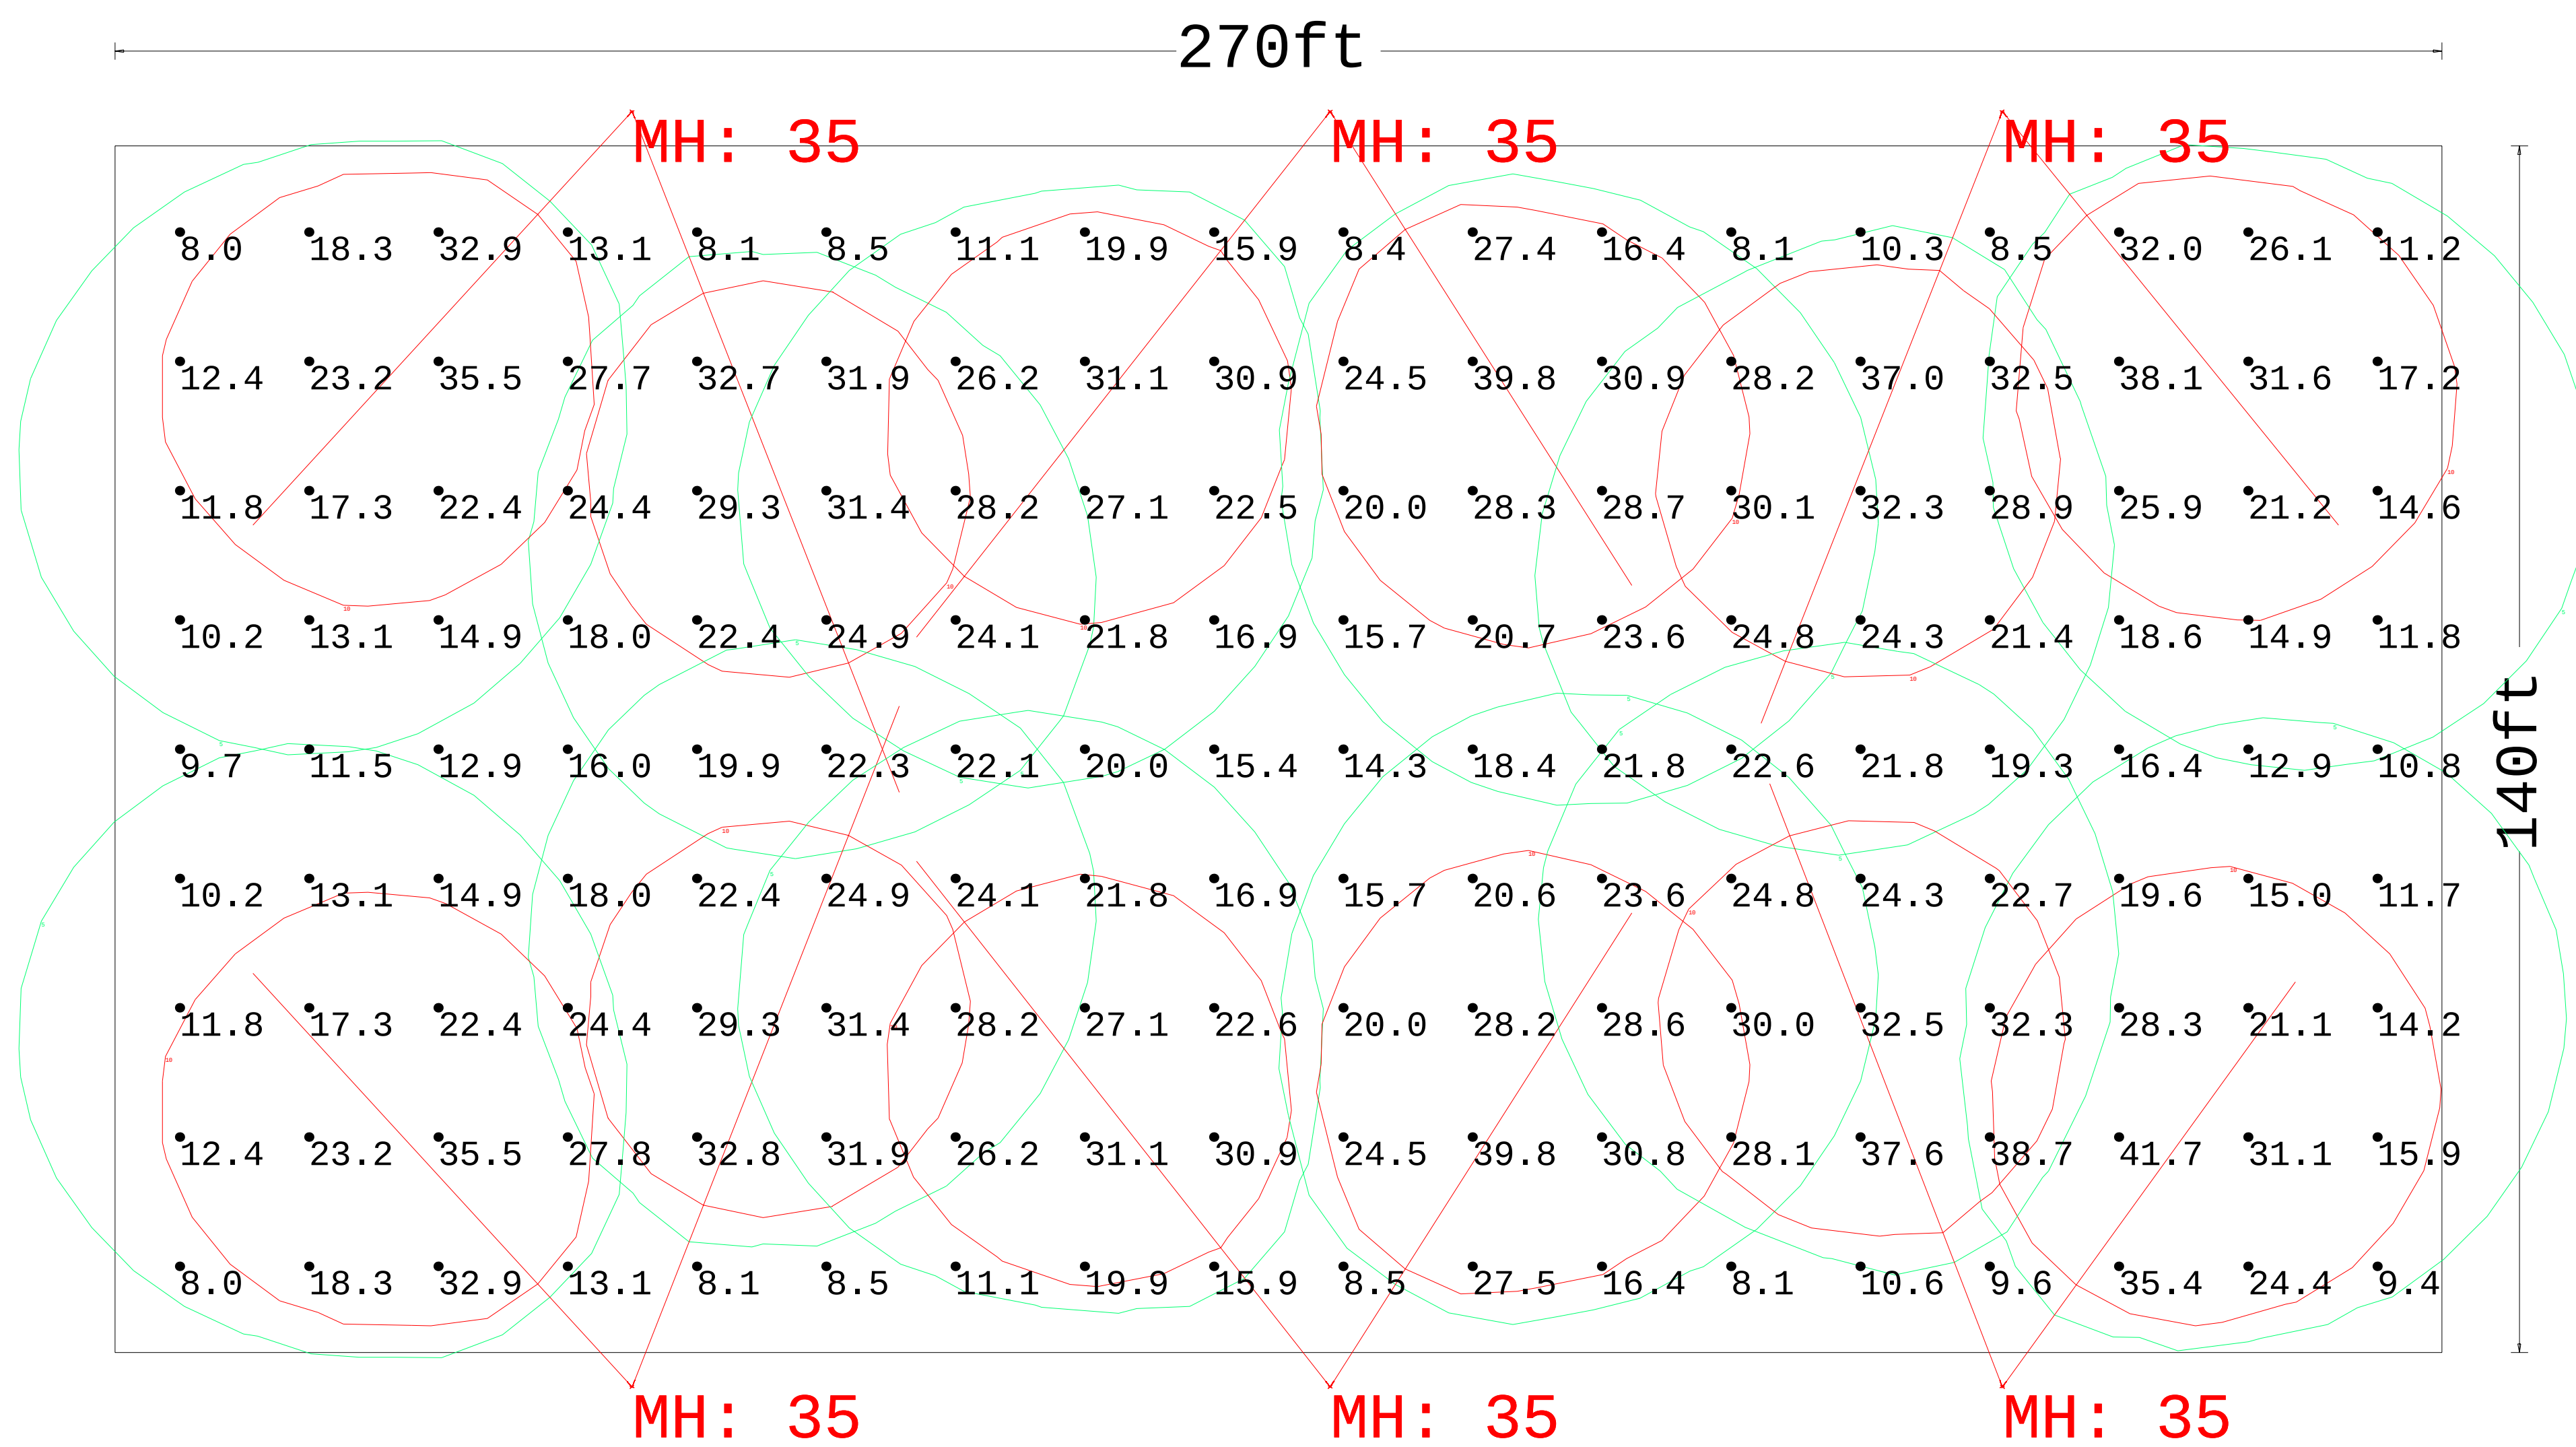

Scale: 1 inch= 15 Ft.

Luminaire Schedule							
Symbol	Qty	Label	Description	LLF	Luminaire Lumens	Luminaire Watts	Total Watts
↗	12	KVG	KVGP60057KDHV55	0.950	96693	608.62	7303.44

Calculation Summary								
Label		CalcType	Units	Avg	Max	Min	Avg/Min	Max/Min
Arena Lighting		Illuminance	Fc	21.79	41.7	8.0	2.72	5.21



Arena lighting

Drawn By:

J

Date:

4/5/2025

REVISIONS

No.	Date	Remark

NOTE:

1. THIS ANALYSIS IS BASED ON COMPUTER DATA DERIVED FROM A FIXTURE TESTED BY AN INDEPENDENT TESTING LABORATORY IN ACCORDANCE WITH ILLUMINATING ENGINEERING SOCIETY APPROVED METHODS & UNDER CONTROLLED CONDITIONS.
2. NO OBJECTS CONSIDERED IN CALCULATION UNLESS OTHERWISE NOTED ON THE PRINT
3. ACTUAL LIGHTING LEVELS MAY VARY DEPENDING ON FIELD CONDITIONS SUCH AS REFLECTANCE AND OBJECTS REVOLVE LED NOT GUARANTEE THE ACTUAL LIGHT LEVELS MEASURED.